



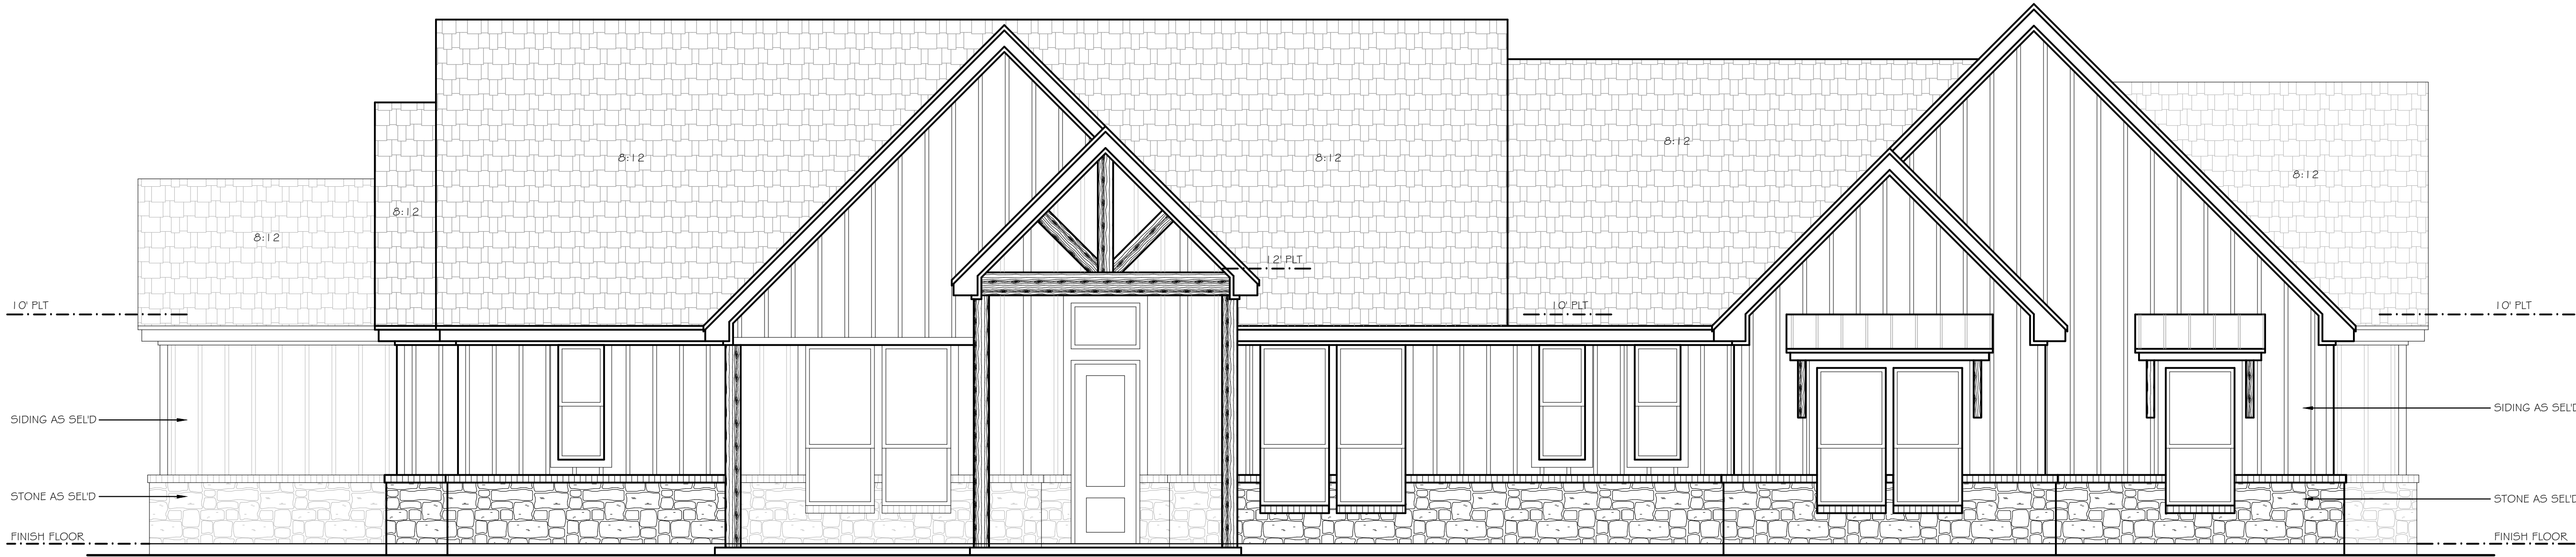

FRONT ELEVATION

SCALE: 1/4"= 1'-0"

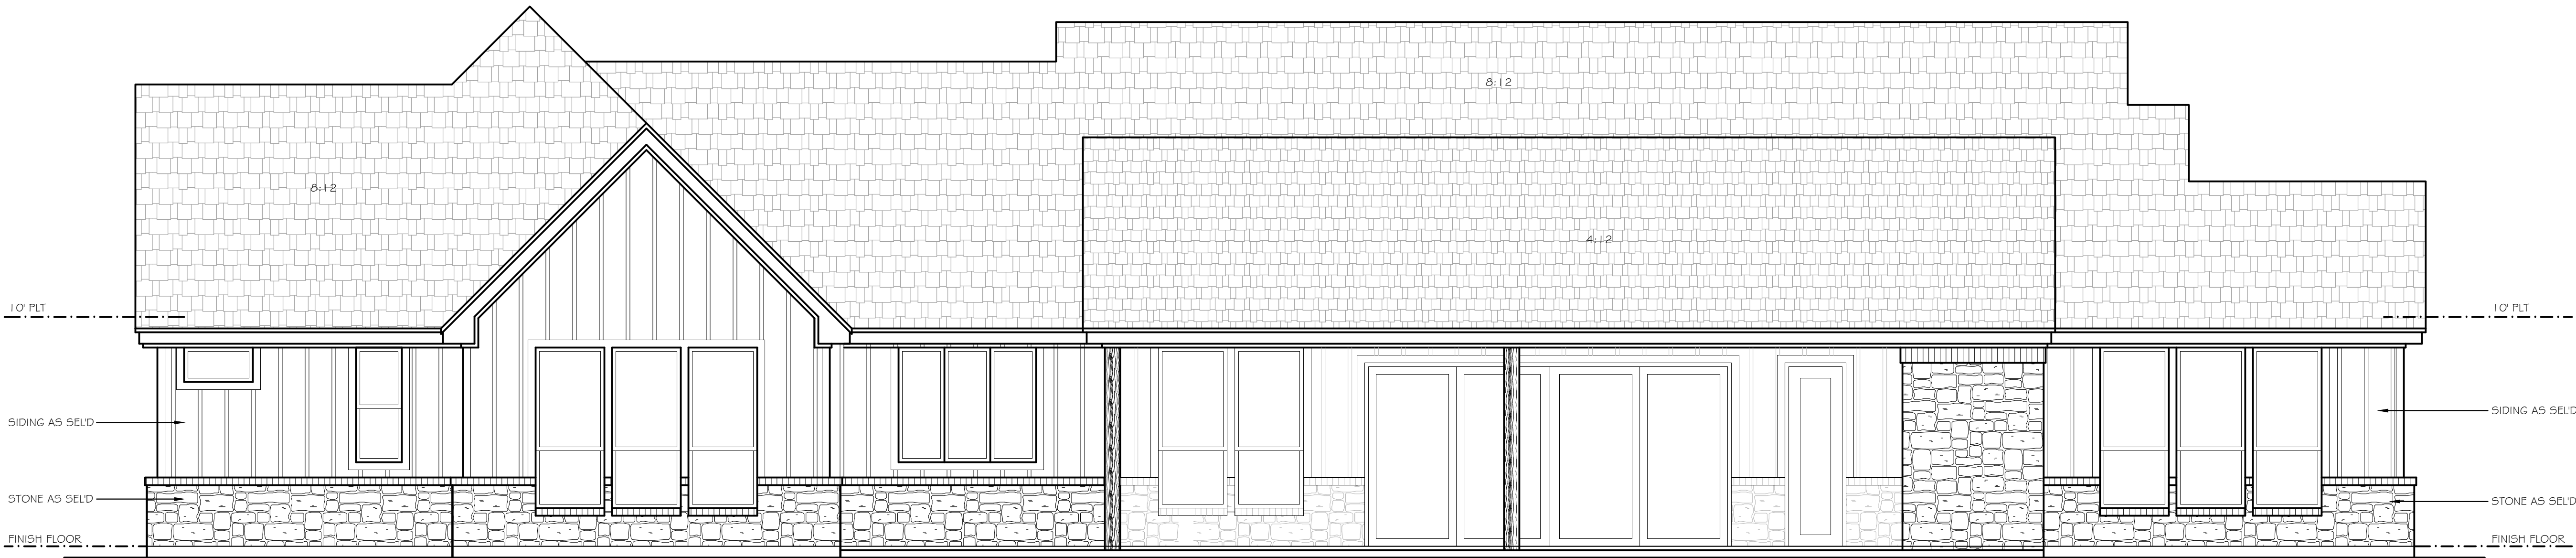

REAR ELEVATION

SCALE: 1/4"= 1'-0"

CUSTOM

Drawn By: CN
Checked By: CN

THESE PLANS ARE INTENDED TO PROVIDE BASIC CONSTRUCTION INFORMATION, AND ARE FOR ARCHITECTURAL DESIGN ONLY. THESE PLANS MUST BE VERIFIED AND CHECKED BY THE CONTRACTOR/OWNER AND ALL CONTRACTORS OF THIS JOB PRIOR TO CONSTRUCTION. CONTRACTOR/OWNER SHOULD OBTAIN ANY ENGINEERING SERVICES NECESSARY BEFORE BEGINNING CONSTRUCTION OF ANY KIND. ALL FEDERAL, STATE, AND LOCAL CODES AND ORDINANCES TAKE PRECEDENCE OVER ANY PART OF THESE PLANS. DESIGNER WILL NOT ASSUME ANY LIABILITY FOR ANY DAMAGES, DUE TO ERRORS, OMISSIONS, OR CHANGES TO THESE PLANS. THE PURCHASE OF THESE PLANS ENTITLES THE BUYER TO CONSTRUCT THIS HOUSE ONLY ONCE. ANY COPYING, TRACING, OR ALTERING OF THESE PLANS IS NOT PERMITTED. VIOLATORS WILL BE SUBJECT TO PROSECUTION UNDER COPYRIGHT LAWS.

INCLUDED IN THIS SET OF PLANS
SITE PLAN (IF NEEDED)
DIMENSIONED FLOOR PLAN
4 ELEVATIONS
ROOF PLAN
ELECTRICAL PLAN
CLASS C FOUNDATION PLAN

A Custom Residence For:

CHRIS THOMAS


Builder:

CHRIS THOMAS

CHAD NORTON

OWNER

(817) 408-5157

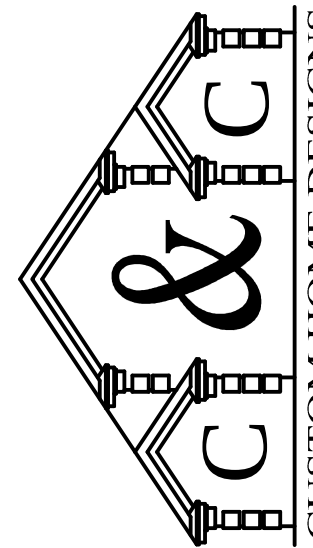

C & C Custom Home Designs

Plan Name:
CTCH SPEC 2025-1
Sheet No:
2 of 6
Date:
8/26/2025 2:57:57 PM



RIGHT ELEVATION

SCALE: 1/4" = 1'-0"



LEFT ELEVATION

SCALE: 1/4" = 1'-0"

CUSTOM

Drawn By:
CN

Checked By:
CN

THESE PLANS ARE INTENDED TO PROVIDE BASIC CONSTRUCTION INFORMATION, AND ARE FOR ARCHITECTURAL DESIGN ONLY. THESE PLANS MUST BE VERIFIED AND CHECKED BY THE CONTRACTOR/OWNER AND ALL CONTRACTORS OF THIS JOB PRIOR TO CONSTRUCTION. CONTRACTOR/OWNER SHOULD OBTAIN ANY ENGINEERING SERVICES NECESSARY BEFORE BEGINNING CONSTRUCTION OF ANY KIND. ALL FEDERAL, STATE, AND LOCAL CODES AND ORDINANCES TAKE PRECEDENCE OVER ANY PART OF THESE PLANS. DESIGNER WILL NOT ASSUME ANY LIABILITY FOR ANY DAMAGES, DUE TO ERRORS, OMISSIONS, OR CHANGES TO THESE PLANS. THE PURCHASE OF THESE PLANS ENTITLES THE BUYER TO CONSTRUCT THIS HOUSE ONLY ONCE. ANY COPYING, TRACING, OR ALTERING OF THESE PLANS IS NOT PERMITTED. VIOLATORS WILL BE SUBJECT TO PROSECUTION UNDER COPYRIGHT LAWS.

INCLUDED IN THIS SET OF PLANS
SITE PLAN (IF NEEDED)
DIMENSIONED FLOOR PLAN
4 ELEVATIONS
ROOF PLAN
ELECTRICAL PLAN
CLASS C FOUNDATION PLAN

A Custom Residence For:

CHRIS THOMAS


Builder:

CHRIS THOMAS

CHAD NORTON

OWNER

(817) 408-5157

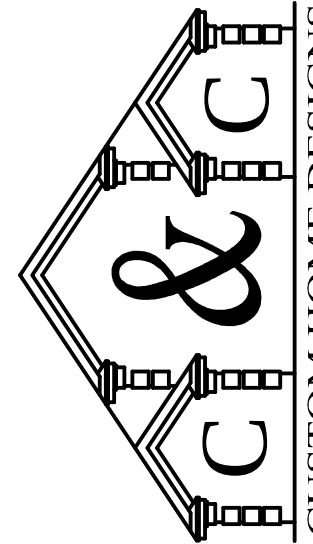


C & C Custom Home Designs

Plan Name:
CTCH SPEC 2025-1

Sheet No:
3 of 6

Date:
8/26/2025 2:58:14 PM

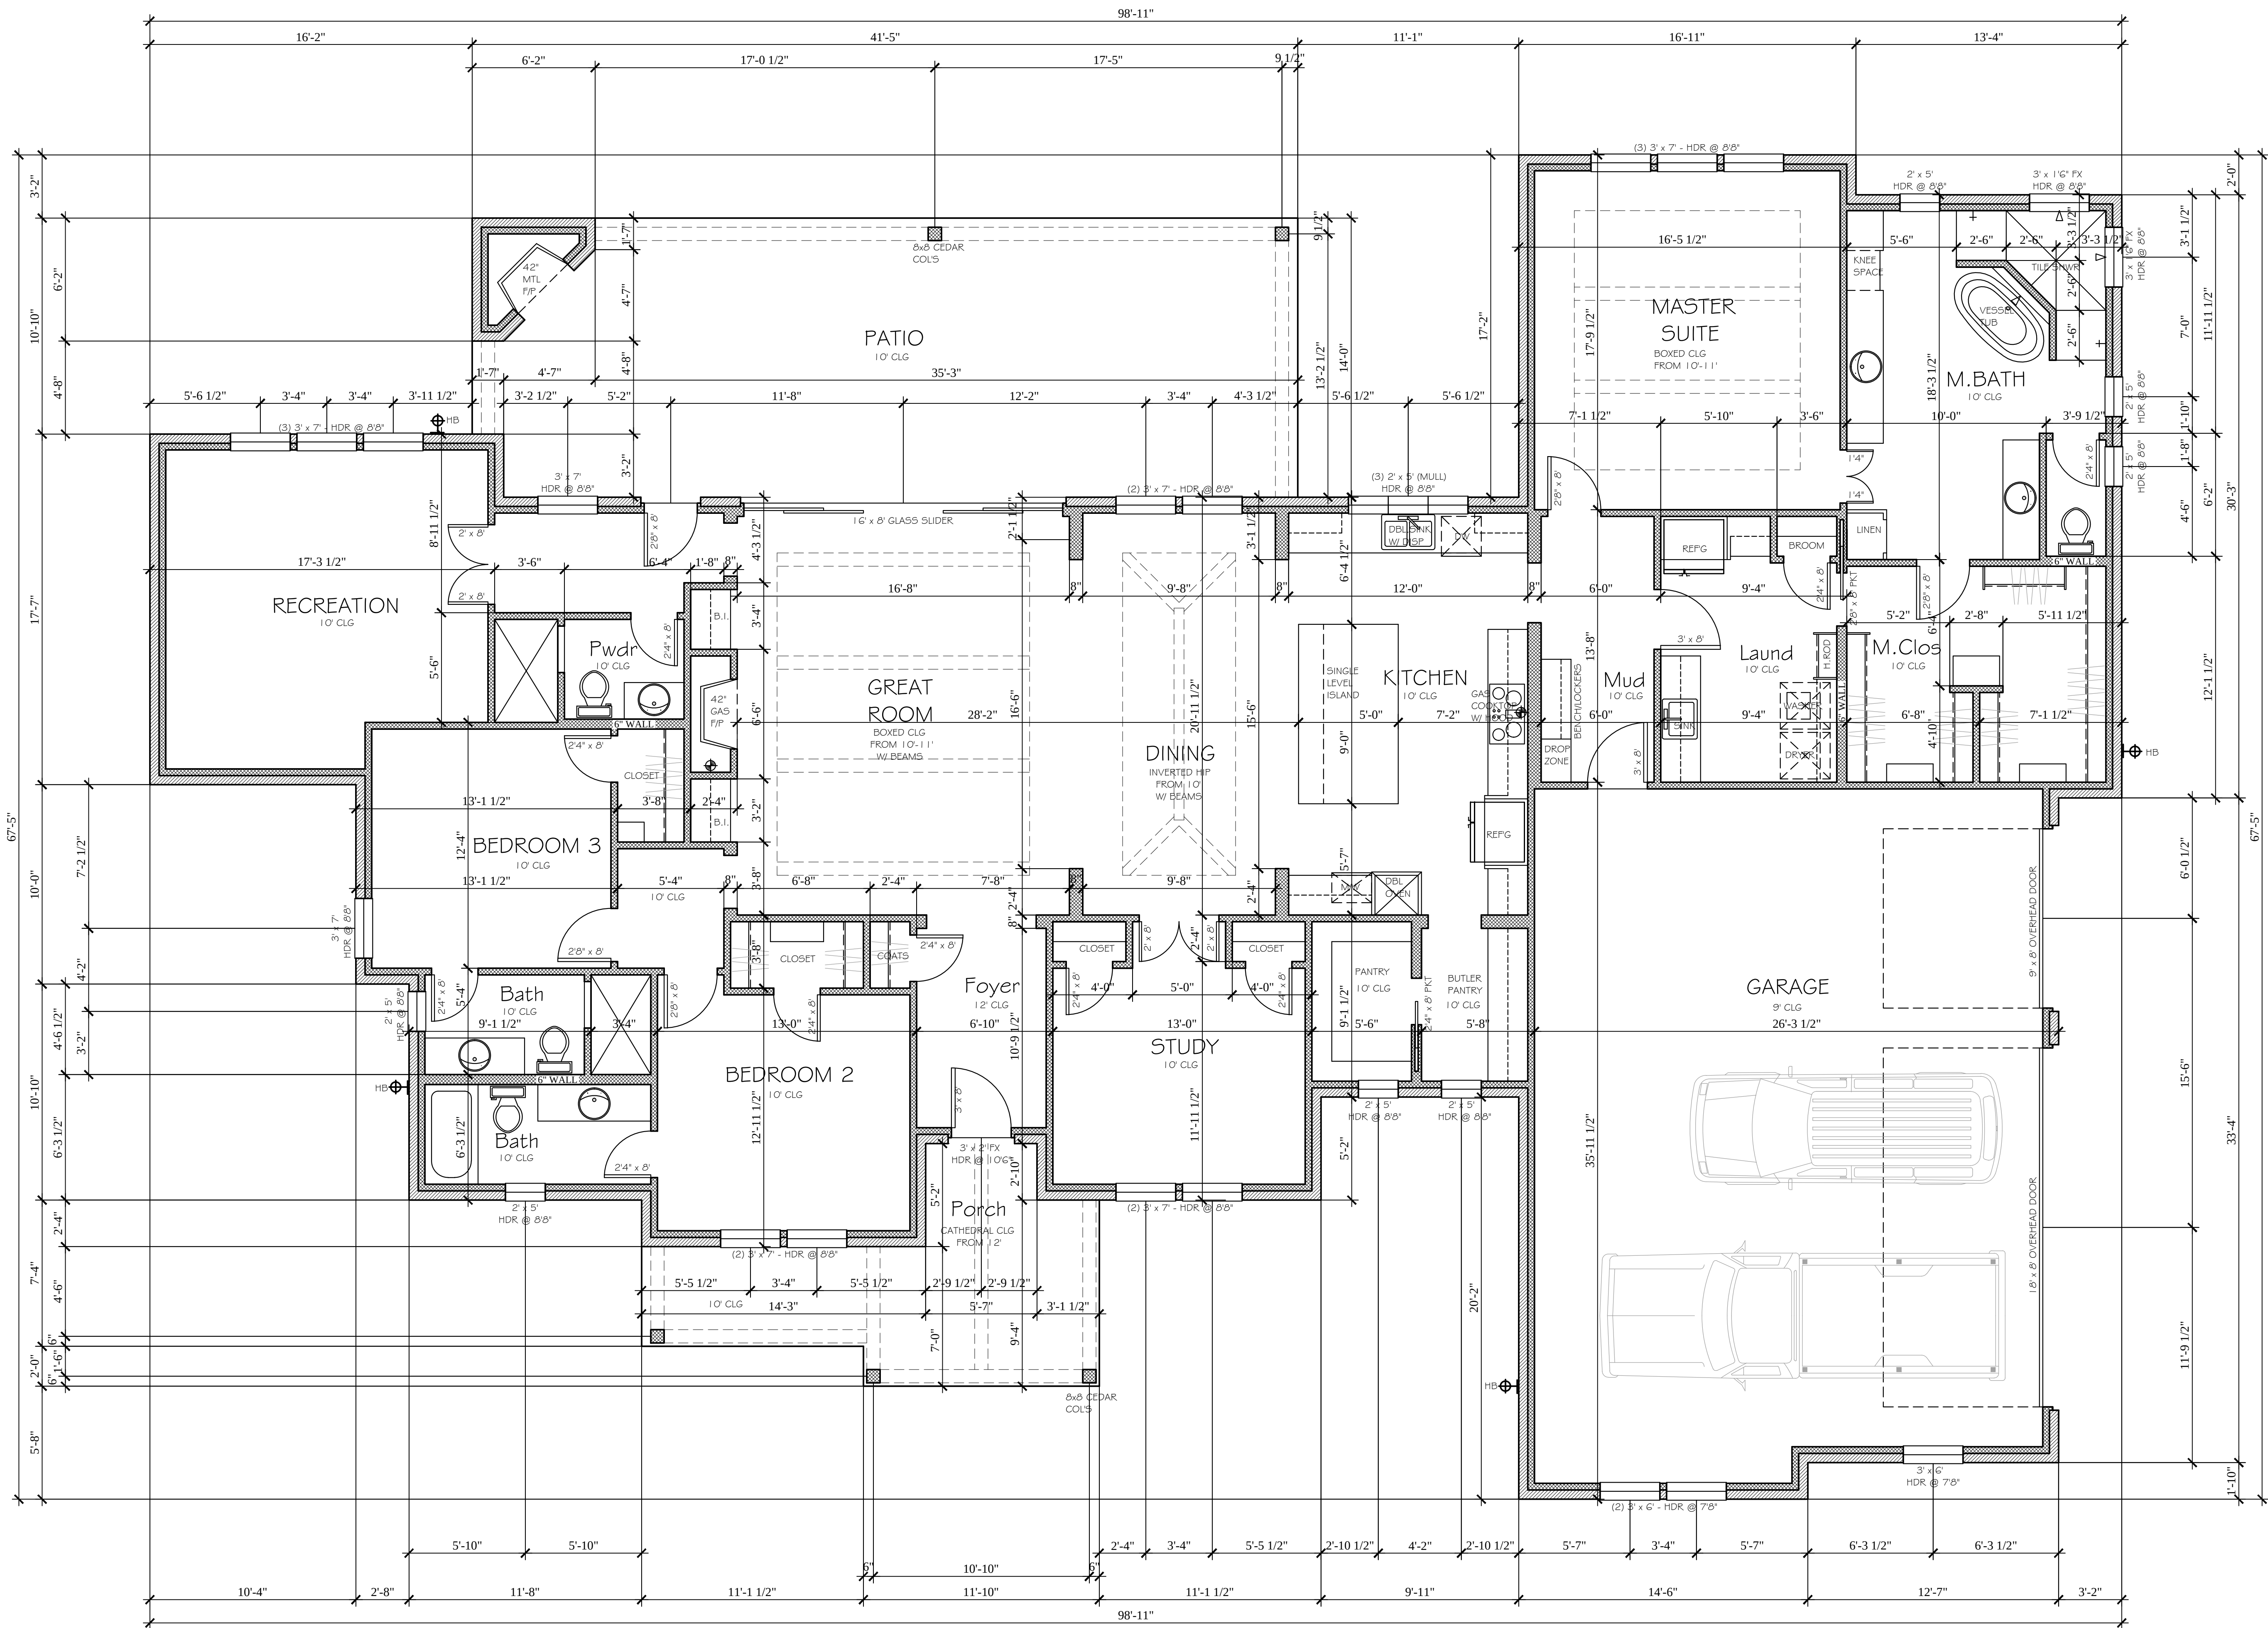

FLOOR PLAN

SCALE: 1/4" = 1'-0"

AREAS	SQ. FT.
TOTAL A/C	3146
PORCH	175
PATIO	575
GARAGE	929
TOTAL AREA UNDER ROOF	4627
TOTAL SLAB	4627

COPYRIGHT 2025

THESE PLANS WERE DESIGNED/DRAWN BY CHAD NORTON D.B.A. C&C CUSTOM HOME DESIGNS. ALL OWNERSHIP AND COPYRIGHT OF THESE PLANS BELONG EXCLUSIVELY TO CHAD NORTON AND C&C CUSTOM HOME DESIGNS. ANY REPRODUCTION, TRACING, OR RE-SELLING OF THESE PLANS IS PROHIBITED AND SUBJECT TO PROSECUTION BY LAW.

CHAD NORTON
OWNER
(817) 408-5157

C & C
CUSTOM HOME DESIGNS
C & C Custom Home Designs

Plan Name:
CTCH SPEC 2025-1

Sheet No:
1 of 6

Date:
8/26/2025 2:57:34 PM

A Custom Residence For:

CHRIS THOMAS

Builder:

CHRIS THOMAS

INCLUDED IN THIS SET OF PLANS

SITE PLAN (IF NEEDED)

DIMENSIONED FLOOR PLAN

4 ELEVATIONS

ROOF PLAN

ELECTRICAL PLAN


CLASS C FOUNDATION PLAN

CUSTOM

Drawn By: CN


Checked By: CN

THESE PLANS ARE INTENDED TO PROVIDE BASIC CONSTRUCTION INFORMATION, AND ARE FOR ARCHITECTURAL DESIGN ONLY. THESE PLANS MUST BE VERIFIED AND CHECKED BY THE CONTRACTOR/OWNER AND ALL CONTRACTORS OF THIS JOB PRIOR TO CONSTRUCTION. CONTRACTOR/OWNER SHOULD OBTAIN ANY ENGINEERING SERVICES NECESSARY BEFORE BEGINNING CONSTRUCTION OF ANY KIND. ALL FEDERAL, STATE, AND LOCAL CODES AND ORDINANCES TAKE PRECEDENCE OVER ANY PART OF THESE PLANS. DESIGNER WILL NOT ASSUME ANY LIABILITY FOR ANY DAMAGES, DUE TO ERRORS, OMISSIONS, OR CHANGES TO THESE PLANS. THE PURCHASE OF THESE PLANS ENTITLES THE BUYER TO CONSTRUCT THIS HOUSE ONLY ONCE. ANY COPYING, TRACING, OR ALTERING OF THESE PLANS IS NOT PERMITTED. VIOLATORS WILL BE SUBJECT TO PROSECUTION UNDER COPYRIGHT LAWS.

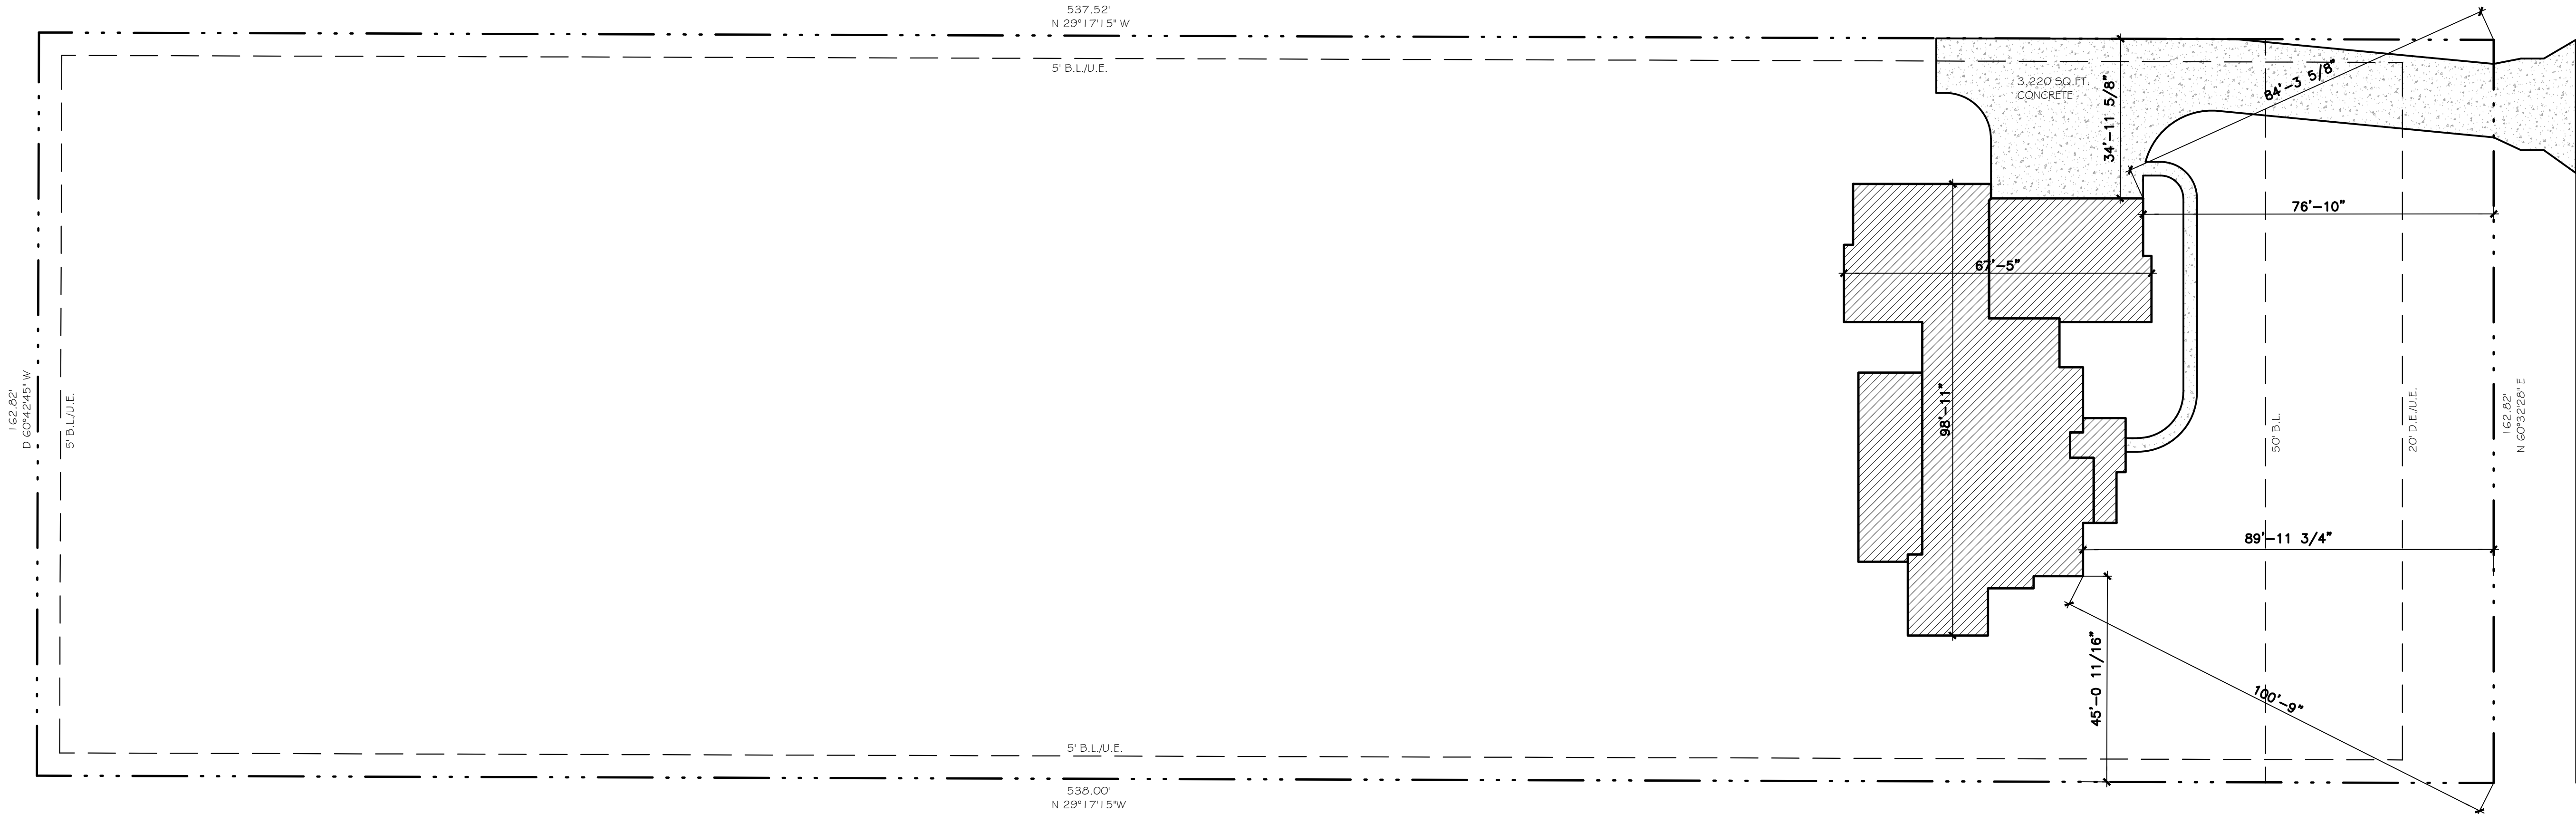

SITE PLAN

SCALE: 1" = 20'-0"

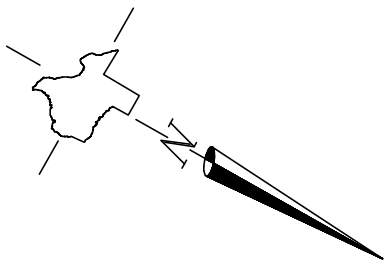


LOT 11
TIMBER VIEW RANCH
A SUBDIVISION IN
PARKER COUNTY, TEXAS

CUSTOM	
Drawn By: CN	Checked By: CN

THESE PLANS ARE INTENDED TO PROVIDE BASIC CONSTRUCTION INFORMATION, AND ARE FOR ARCHITECTURAL DESIGN ONLY. THESE PLANS MUST BE VERIFIED AND CHECKED BY THE CONTRACTOR/OWNER AND ALL CONTRACTORS OF THIS JOB PRIOR TO CONSTRUCTION. CONTRACTOR/OWNER SHOULD OBTAIN ANY ENGINEERING SERVICES NECESSARY BEFORE BEGINNING CONSTRUCTION OF ANY KIND. ALL FEDERAL, STATE, AND LOCAL CODES AND ORDINANCES TAKE PRECEDENCE OVER ANY PART OF THESE PLANS. DESIGNER WILL NOT ASSUME ANY LIABILITY FOR ANY DAMAGES, DUE TO ERRORS, OMISSIONS, OR CHANGES TO THESE PLANS. THE PURCHASE OF THESE PLANS ENTITLES THE BUYER TO CONSTRUCT THIS HOUSE ONLY ONCE. ANY COPYING, TRACING, OR ALTERING OF THESE PLANS IS NOT PERMITTED. VIOLATORS WILL BE SUBJECT TO PROSECUTION UNDER COPYRIGHT LAWS.

INCLUDED IN THIS SET OF PLANS	
A Custom Residence For: CHRIS THOMAS	SITE PLAN (IF NEEDED)
	DIMENSIONED FLOOR PLAN
	4 ELEVATIONS
	ROOF PLAN
	ELECTRICAL PLAN
Builder: CHRIS THOMAS	

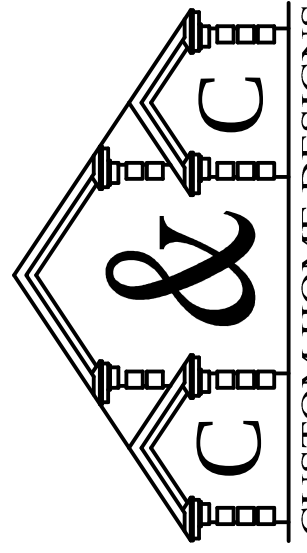

CUSTOM HOME DESIGNS
C & C Custom Home Designs

CHAD NORTON
OWNER
(817) 408-5157

Plan Name: CTCH SPEC 2025-1
Sheet No: SITE PLAN
Date: 8/26/2025 3:00:49 PM